


RIPRAP BANK PROTECTION



NOTE: THE LIMITS OF DISTURBANCE HAVE BEEN REVISED TO MINIMIZE ADJACENT WETLAND AND TREE IMPACTS TO THE MAXIMUM EXTENT PRACTICABLE. WETLANDS OUTSIDE THE PROJECT PERIMETER WILL NOT BE DISTURBED OR IMPACTED.

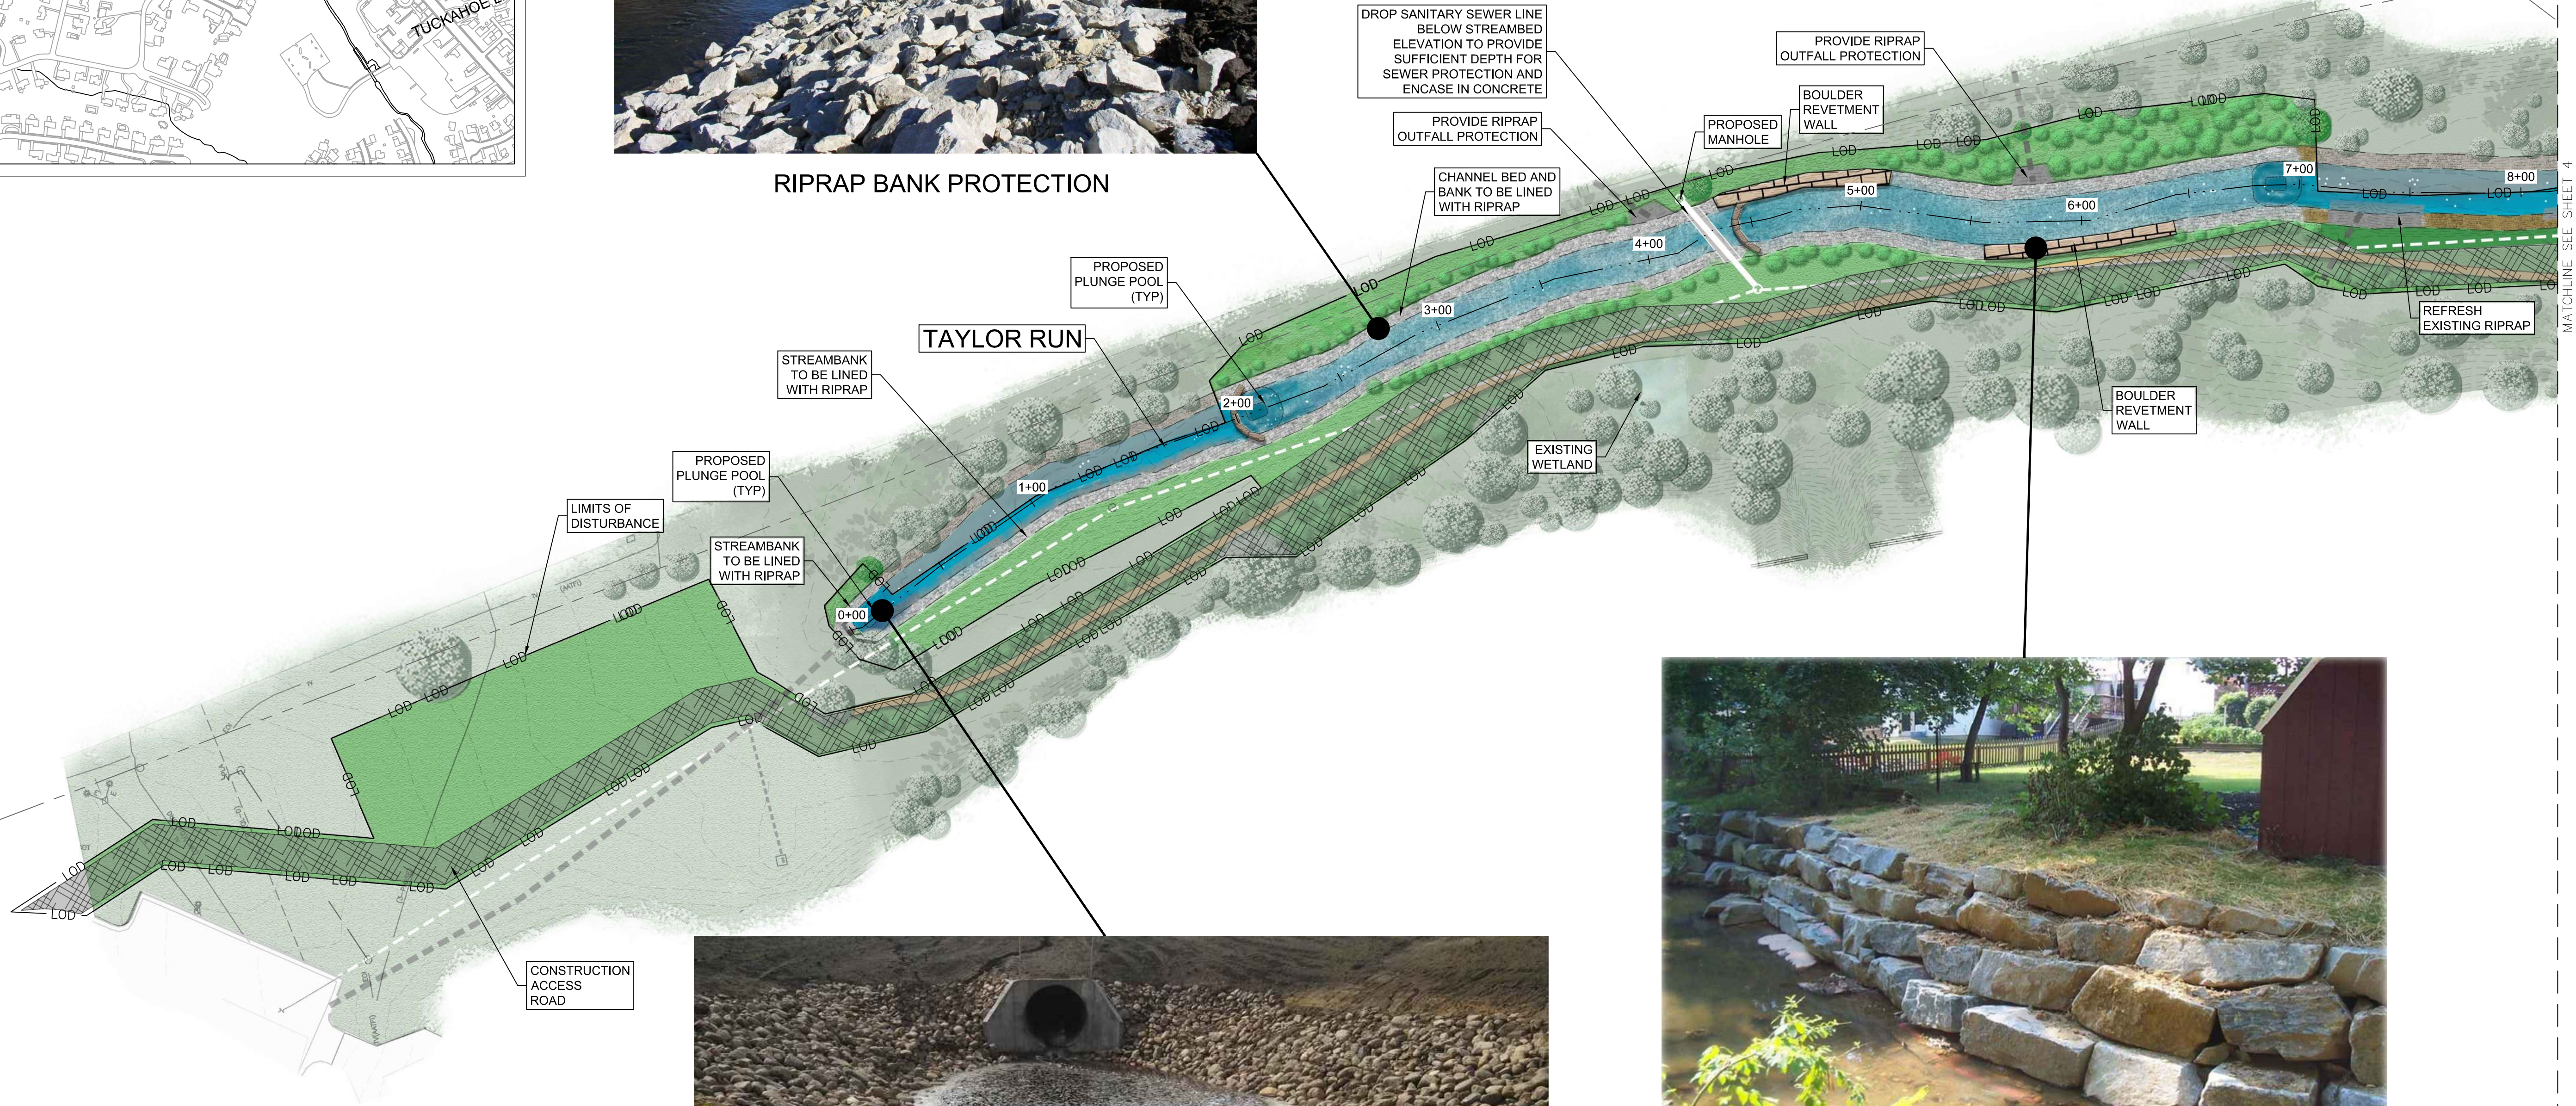

RIPRAP PLUNGE POOL



BOULDER REVETMENT WALL

SOURCE DATA INFORMATION
H.D. = VCS NAD 83
V.D. = NAVD 88
GIS INFO = CITY & WSSI DIG. DATA

40 20 0 40 80 120
SCALE: 1"=40'

CONCEPTUAL DESIGN

CITY OF ALEXANDRIA, VIRGINIA
DEPARTMENT OF PROJECT IMPLEMENTATION
301 KING ST., RM 3200
ALEXANDRIA, VA 22314

REVISIONS	DATE	DESCRIPTION

SEAL:

HARD ARMORING DESIGN
PROPOSED CONDITIONS

URS
1400 MISTING CENTER BL. SUITE 400
GERMANTOWN, VA 22031
(703) 552-3000


TAYLOR RUN STREAM STABILIZATION

DRAWING
GP - 01
SCALE 1"=40'
SHEET 3 OF 5

L:\DCS Projects\NRA\City of Alexandria\VPRES-100 2013\TO 41 Stream Channel Alternatives\000 CAD\910 CAD\Taylor Run Design Files\20-SHEETS\PROPOSED SITE PLAN - Overall.dwg Plotted: 8/16/2022 9:20 AM by Burgess, Emily

C:\Users\lauren.weslowski\Desktop\Taylor Run Design Files\20-SHEETS\PROPOSED SITE PLAN - Overall.dwg Plotted: 8/25/2022 3:04 PM by Weslowski, Lauren

NOTE: THE LIMITS OF DISTURBANCE HAVE BEEN REVISED TO MINIMIZE ADJACENT WETLAND AND TREE IMPACTS TO THE MAXIMUM EXTENT PRACTICABLE. WETLANDS OUTSIDE THE PROJECT PERIMETER WILL NOT BE DISTURBED OR IMPACTED.

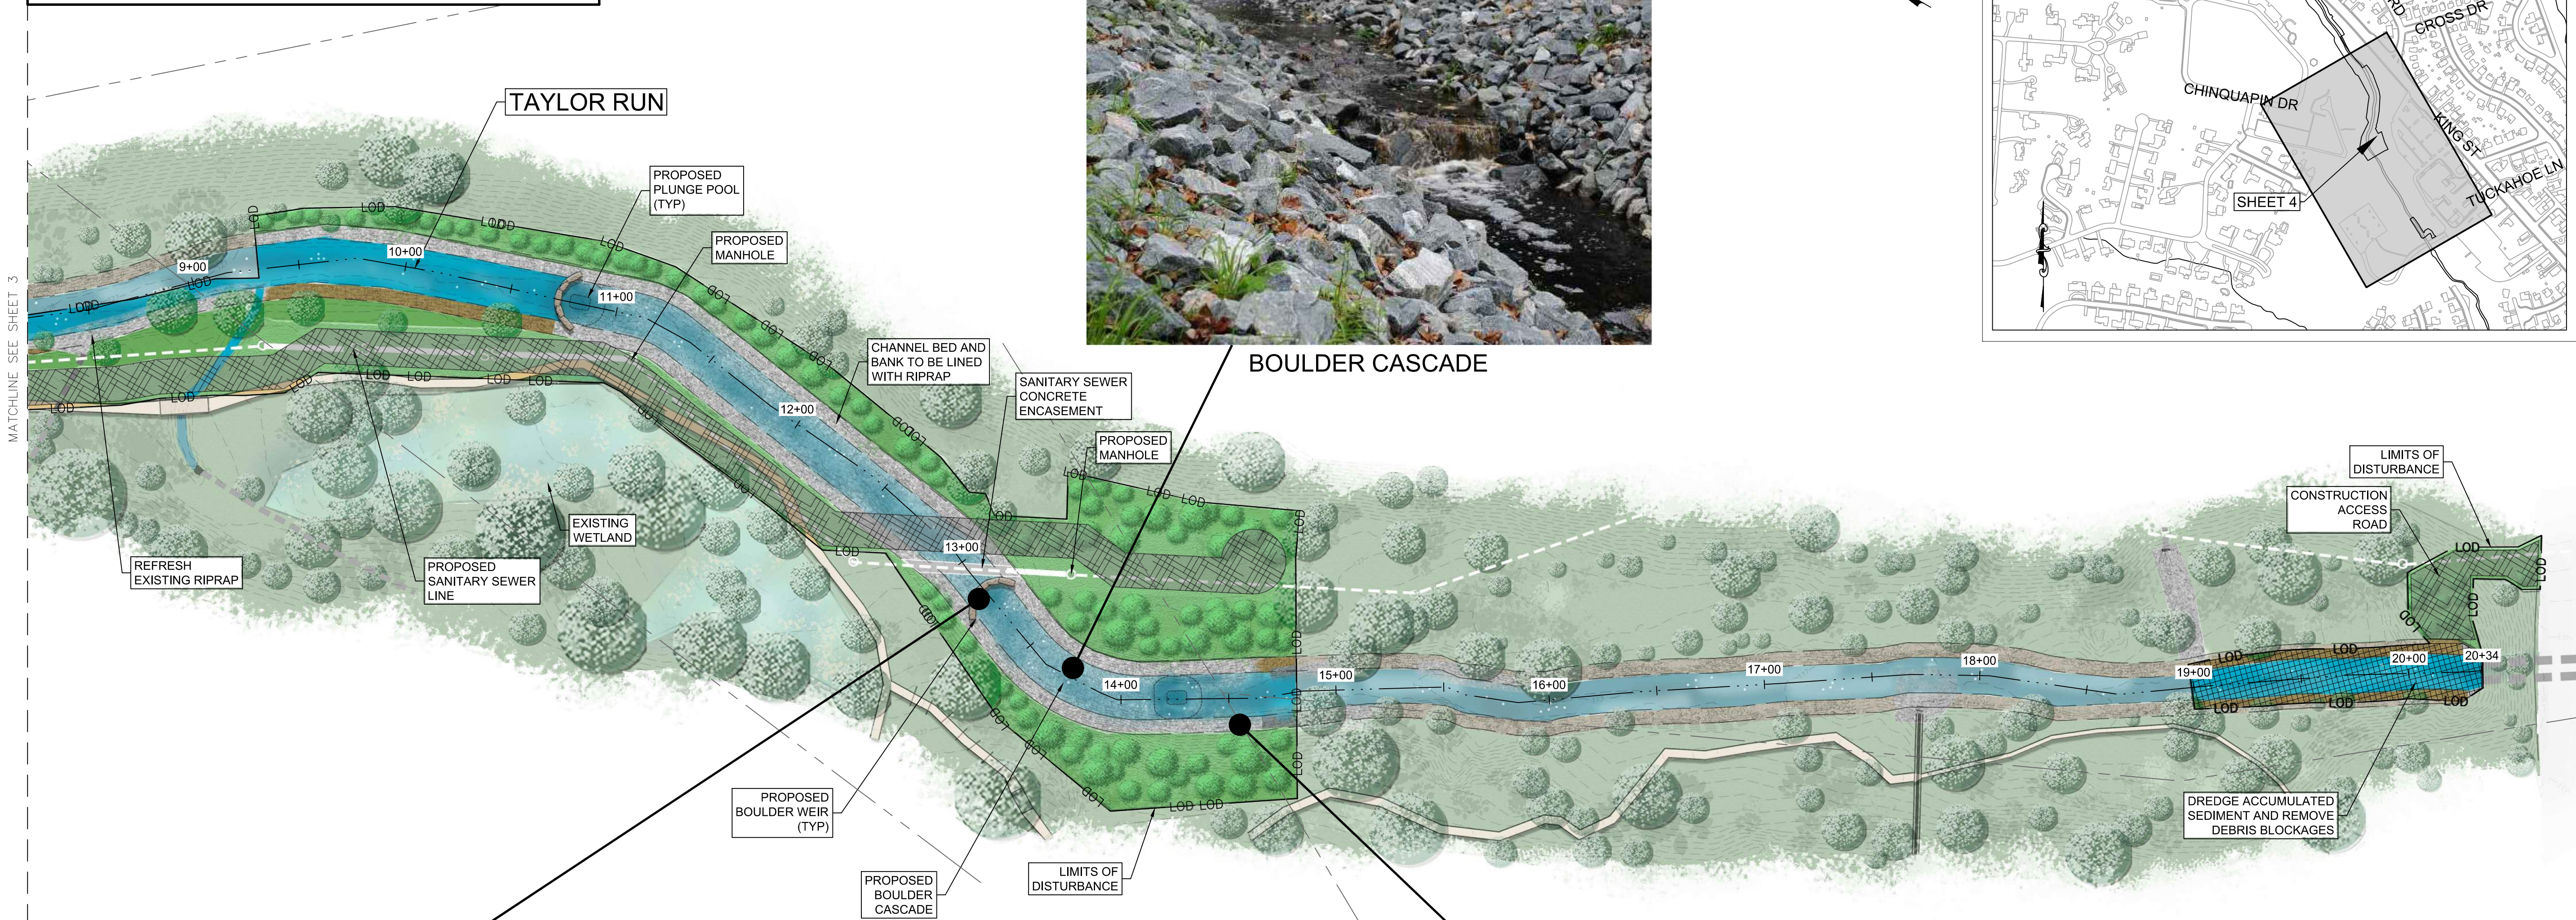



BOULDER CASCADE



BOULDER WEIR



RIPRAP BANK PROTECTION

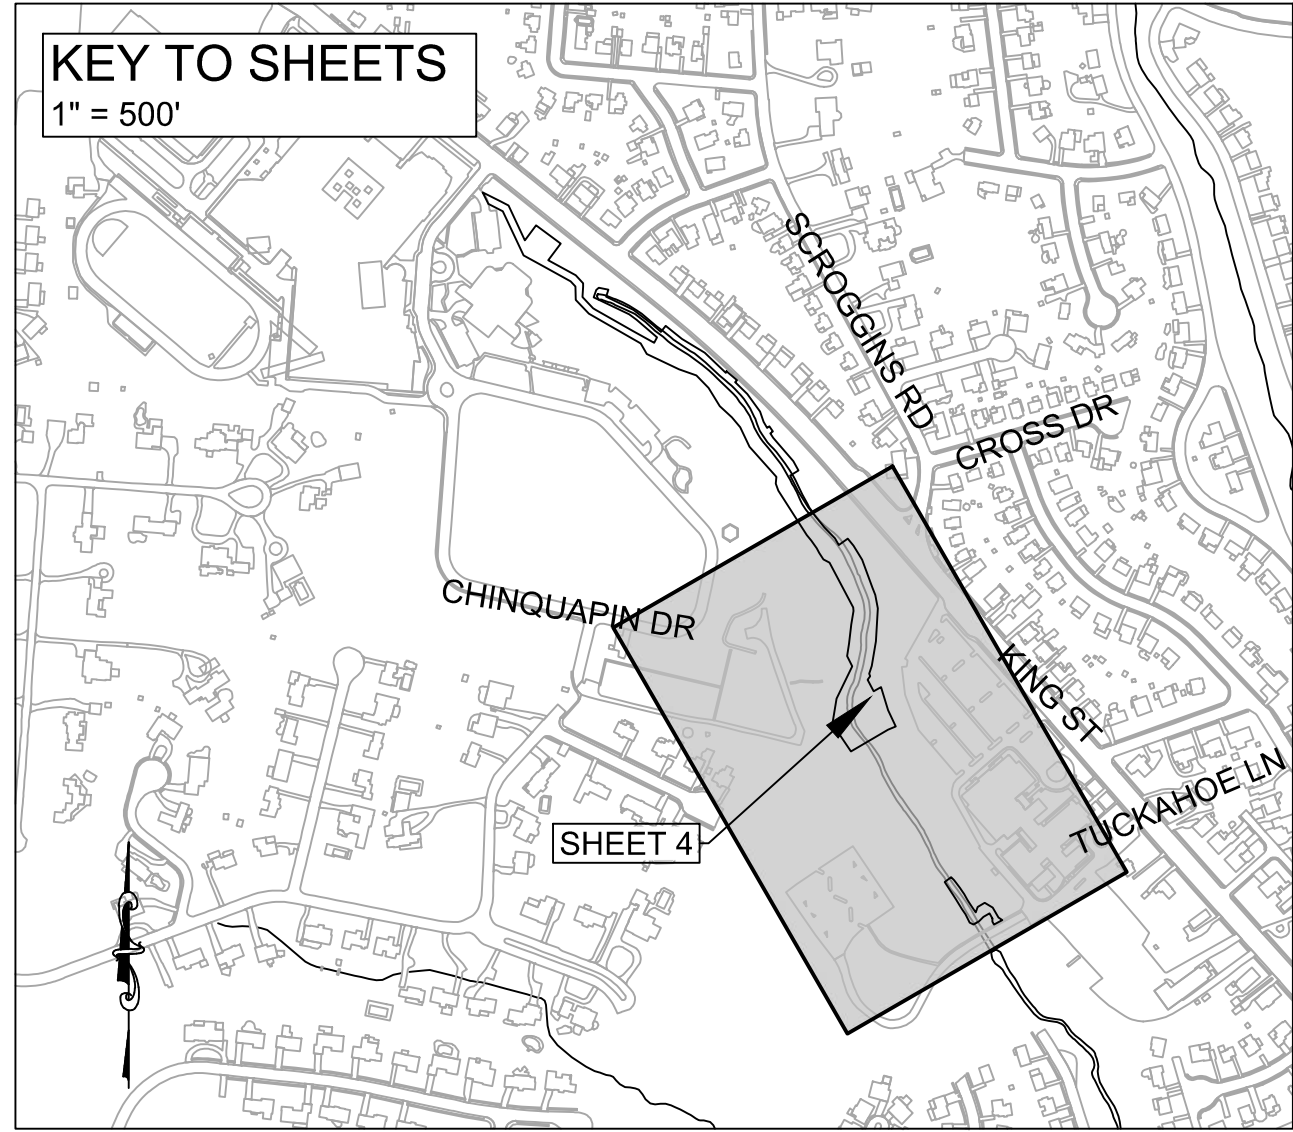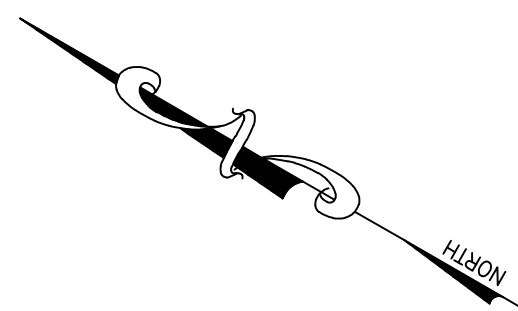

SOURCE DATA INFORMATION
H.D. = VCS NAD 83
V.D. = NAVD 88
GIS INFO = CITY & WSSI DIG. DATA

40 20 0 40 80 120
SCALE: 1"=40'

CITY OF ALEXANDRIA, VIRGINIA
DEPARTMENT OF PROJECT
IMPLEMENTATION
301 KING ST., RM 3200
ALEXANDRIA, VA 22314

CONCEPTUAL DESIGN

REVISIONS	DATE	DESCRIPTION

CITY PROJECT NO: TO-41
DATE OF PLAN ISSUANCE: XX/XX/XX
CONSULTANT PROJECT ID: 60668730
DESIGNED BY: ST DATE: 7/19/22
DRAWN BY: ST DATE: 7/19/22
CHECKED BY: BWA DATE: 7/19/22
APPROVED BY: BWA DATE: 7/19/22

SEAL:


HARD ARMORING DESIGN
PROPOSED CONDITIONS

URS
1400 MISTING CENTER DR. SUITE 400
GERMANTOWN, MD 20876
(301) 455-3000

TAYLOR RUN STREAM STABILIZATION

DRAWING
GP - 02
SCALE 1"=40'
SHEET 4 OF 5

C:\Users\saratiano\Desktop\Alexandria\CAID\Taylor Run Design Files\20-SHEETS\PROPOSED PROFILE.dwg Plotted: 3/11/2022 2:48 PM by Tolox, Sara

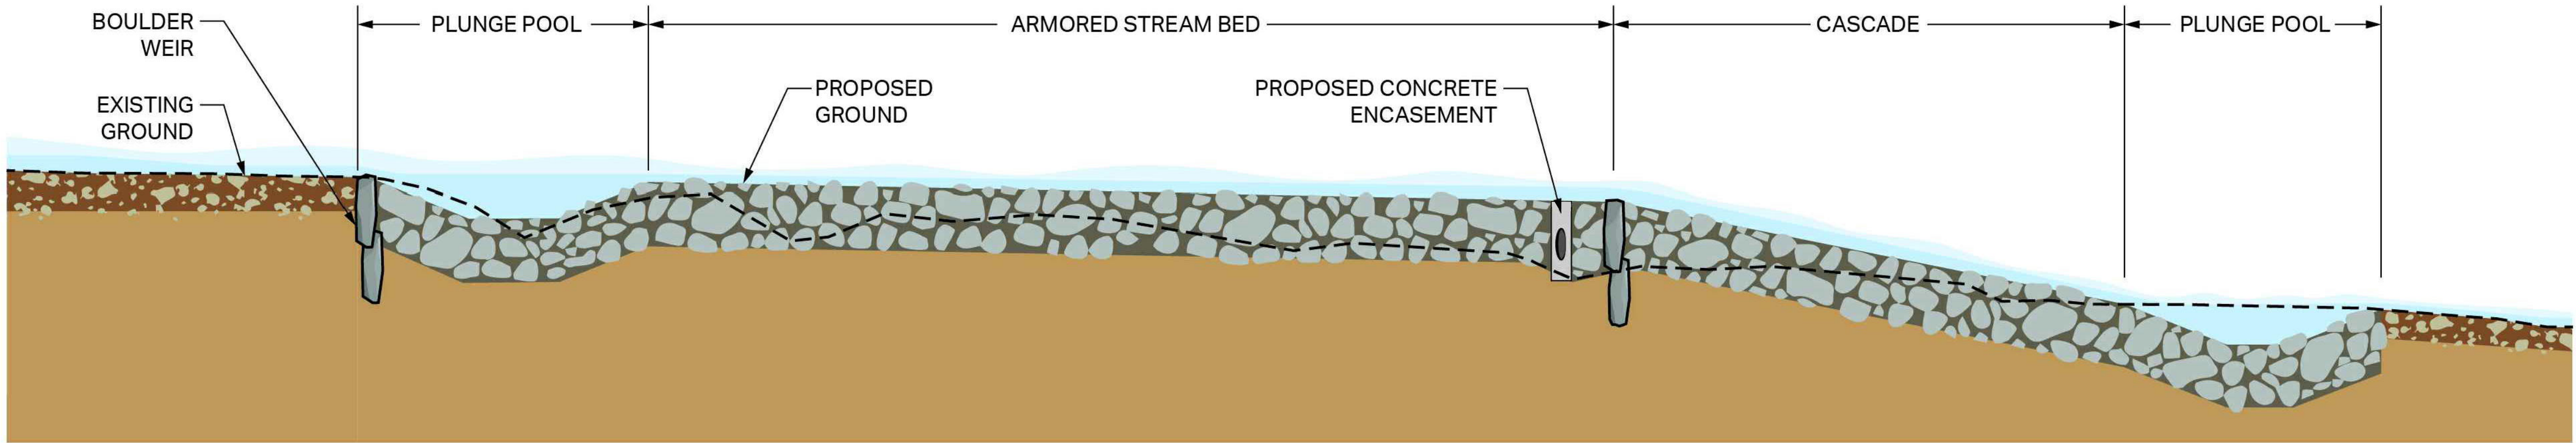


TYPICAL SANITARY SEWER PROTECTION LONGITUDINAL PROFILE

TAYLOR RUN STREAM STABILIZATION

DRAWING
LP - 01
SCALE N/A
SHEET 5 OF 5

TYPICAL PROFILE
VIEW



URS
1400 MIDDLEBURY STREET, SUITE 400
GARDEN CITY, NY 11530
(516) 466-9000

SEAL:

CITY PROJECT NO.: TO-41
DATE OF PLAN ISSUANCE: XX/XX/XX
CONSULTANT PROJECT ID.: 50668730
DESIGNED BY: ST DATE: 2/4/22
DRAWN BY: ST DATE: 2/4/22
CHECKED BY: BWA DATE: 2/4/22
APPROVED BY: BWA DATE: 2/4/22

DATE	REVISIONS BY	DESCRIPTION

CITY OF ALEXANDRIA, VIRGINIA
DEPARTMENT OF PROJECT
IMPLEMENTATION
301 KING ST., RM 3200
ALEXANDRIA, VA 22314



CONCEPTUAL DESIGN